


2023 SEWER REHABILITATION TOWN OF CAMPBELL, WISCONSIN

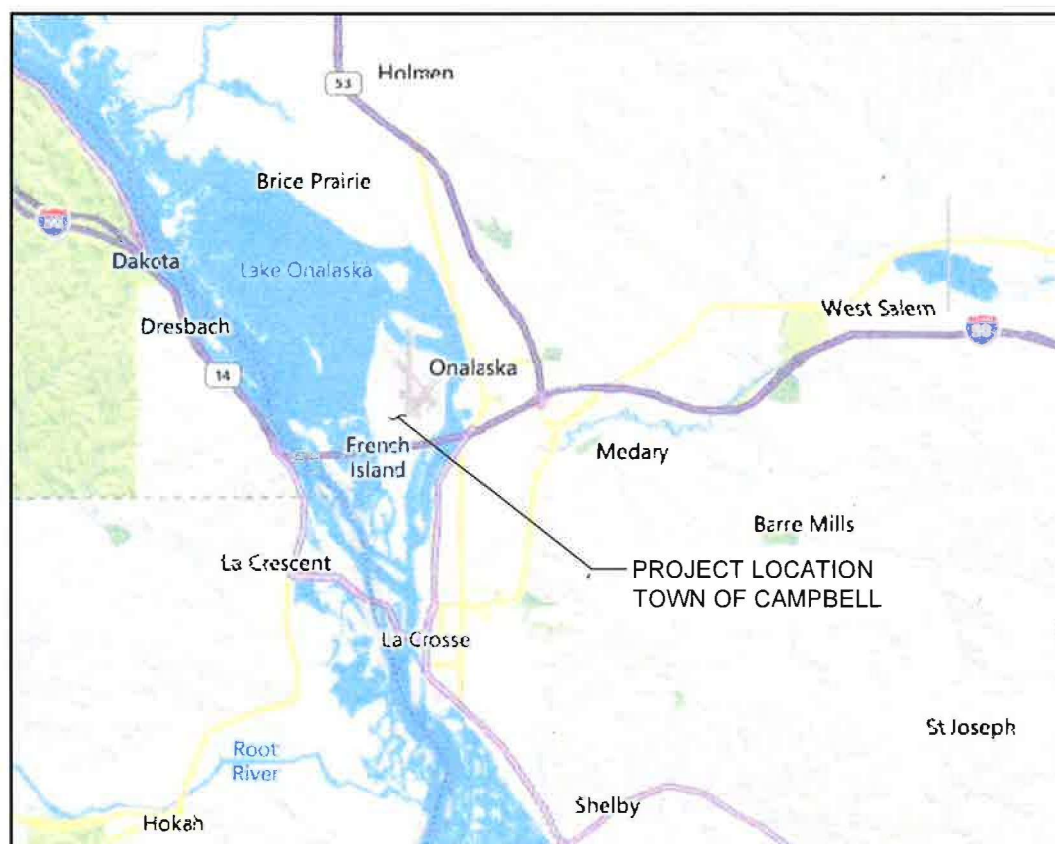


SHEET INDEX

SHEET NUMBER	DESCRIPTION
1.	COVER & INDEX OF SHEETS
2.	GENERAL NOTES & SYMBOLS
3.	PROJECT LOCATION MAP - SOUTH
4.	PROJECT LOCATION & TRAFFIC CONTROL PLAN
5.	TYPICAL CROSS SECTION
6.	CAROLINE ST. PLAN & PROFILE
7.	CHEROKEE AVE. PLAN & PROFILE
8.	CHEROKEE AVE. POINT REPAIRS
9.	NAKOMIS AVE POINT REPAIRS - 1
10.	NAKOMIS AVE POINT REPAIRS - 2
11.	NAKOMIS AVE POINT REPAIRS - 3
12.	NAKOMIS AVE POINT REPAIRS - 4
13.	GODDARD ST POINT REPAIRS
14.	2ND AVE & LAFOND AVE POINT REPAIRS
15.	LA FOND AVE. DRAINAGE IMPROVEMENTS
16.	LA FOND AVE. DRAINAGE DETAILS
17.	SANITARY SEWER DETAILS
18.	TRACER WIRE DETAILS
19.	EROSION CONTROL DETAILS





DAVY ENGINEERING CO.
LA CROSSE, WISCONSIN

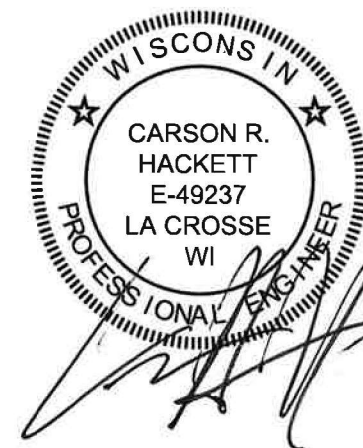

PROJECT NO. 1331-177.020

JANUARY 2023

 H:\AutoCad Drawings\2020\Campbell\1331-177 2023 Sewer Rehabilitation\CAD Drawings\Civil\DELIVERABLES\1331-177 Project Location Map - Traffic Control Plan adjusted const.dwg, 1/24/2023 8:19:20 AM

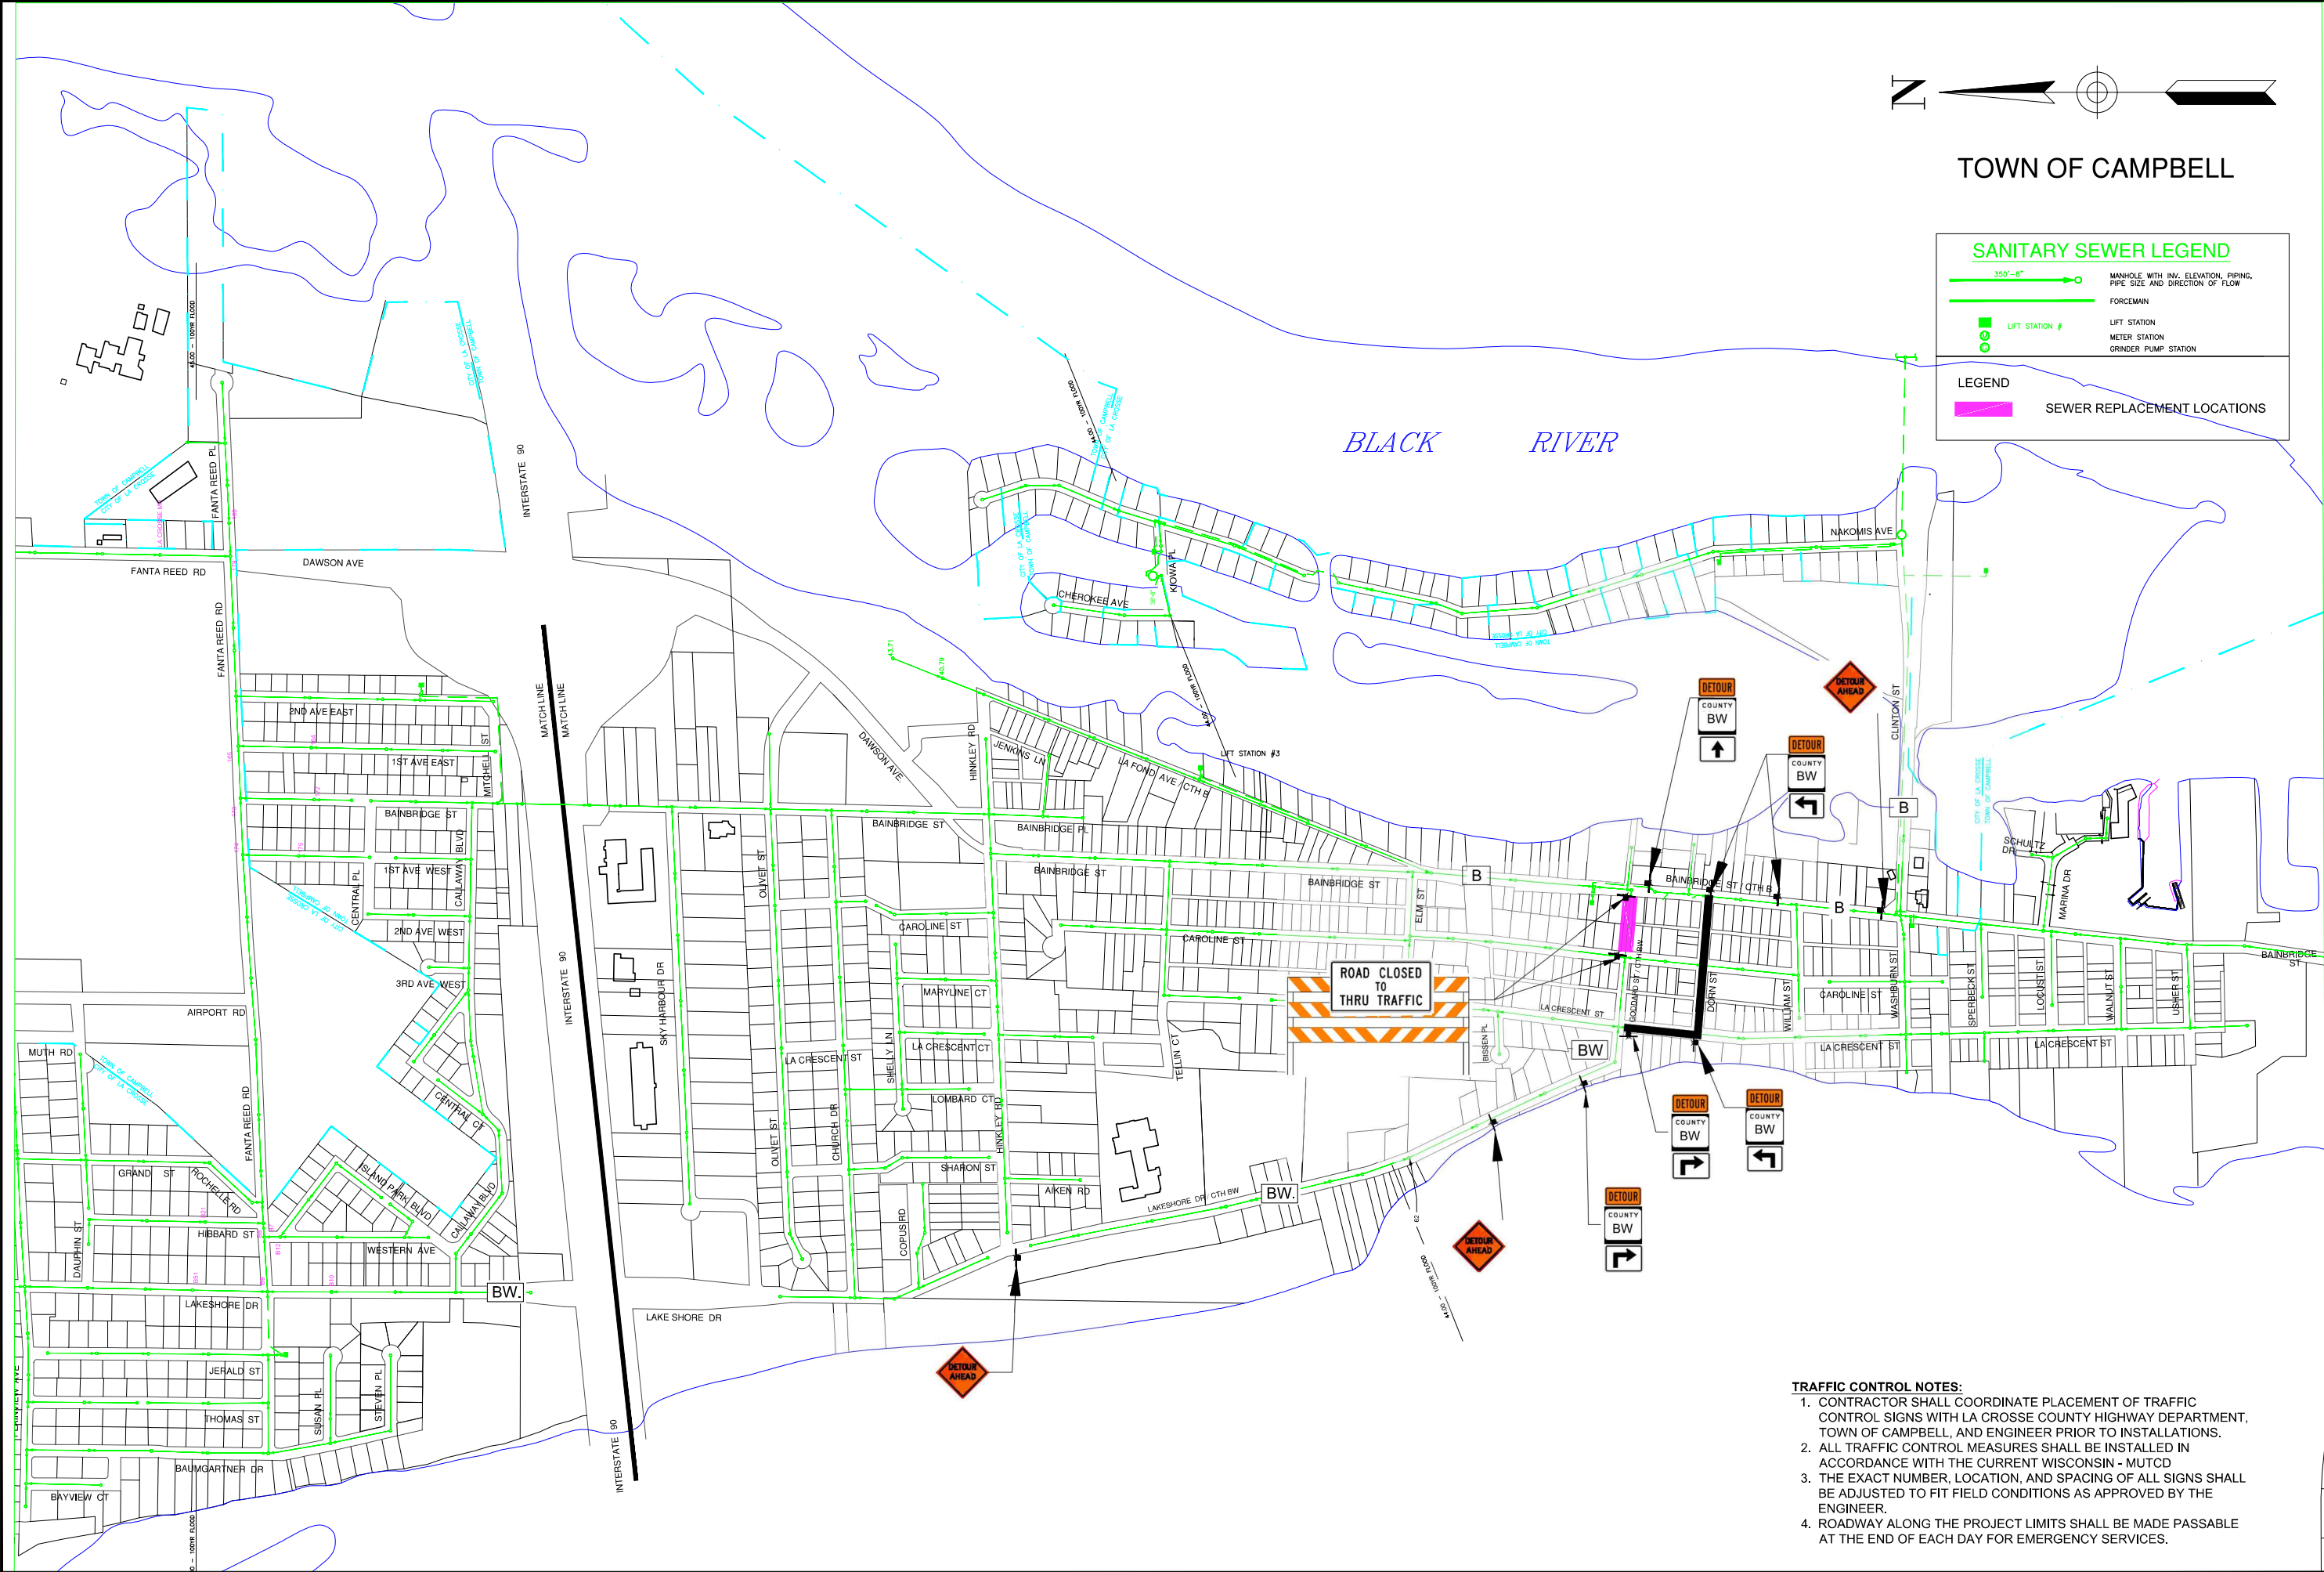

TOWN OF CAMPBELL

SANITARY SEWER LEGEND

350"-8" MANHOLE WITH INV. ELEVATION, PIPING, PIPE SIZE AND DIRECTION OF FLOW

FORCEMAIN

LIFT STATION # LIFT STATION METER STATION GRINDER PUMP STATION

LEGEND

SEWER REPLACEMENT LOCATIONS

- TRAFFIC CONTROL NOTES:**
1. CONTRACTOR SHALL COORDINATE PLACEMENT OF TRAFFIC CONTROL SIGNS WITH LA CROSSE COUNTY HIGHWAY DEPARTMENT, TOWN OF CAMPBELL, AND ENGINEER PRIOR TO INSTALLATIONS.
 2. ALL TRAFFIC CONTROL MEASURES SHALL BE INSTALLED IN ACCORDANCE WITH THE CURRENT WISCONSIN - MUTCD
 3. THE EXACT NUMBER, LOCATION, AND SPACING OF ALL SIGNS SHALL BE ADJUSTED TO FIT FIELD CONDITIONS AS APPROVED BY THE ENGINEER.
 4. ROADWAY ALONG THE PROJECT LIMITS SHALL BE MADE PASSABLE AT THE END OF EACH DAY FOR EMERGENCY SERVICES.

PROJECT LOCATION MAP/TRAFFIC CONTROL 2023 SEWER REHABILITATION TOWN OF CAMPBELL, WISCONSIN	 DAVY ENGINEERING CO. LA CROSSE, WISCONSIN	FIELD BOOK:		REVISION DATE	REMARKS
		SCALE: AS SHOWN			
		DRAWN: KK/CSM			
		CHECKED: CRH			
		DATE: 01/19/2023			
PROJECT NUMBER 1331-177.020					
SHEET NO. 4					



DAVY ENGINEERING CO.
LA CROSSE, WISCONSIN

PROJECT LOCATION MAP/TRAFFIC CONTROL
2023 SEWER REHABILITATION
TOWN OF CAMPBELL, WISCONSIN

PROJECT NUMBER
1331-177.020

SHEET NO.
4

H:\AutoCad Drawings\2020\C\Campbell\1331-177 2023 Sewer Rehabilitation\CAD Drawings\Civil\DELIVERABLES\SHEET-20+00.00 TO 29+26.17.dwg, 1/24/2023 8:24:49 AM

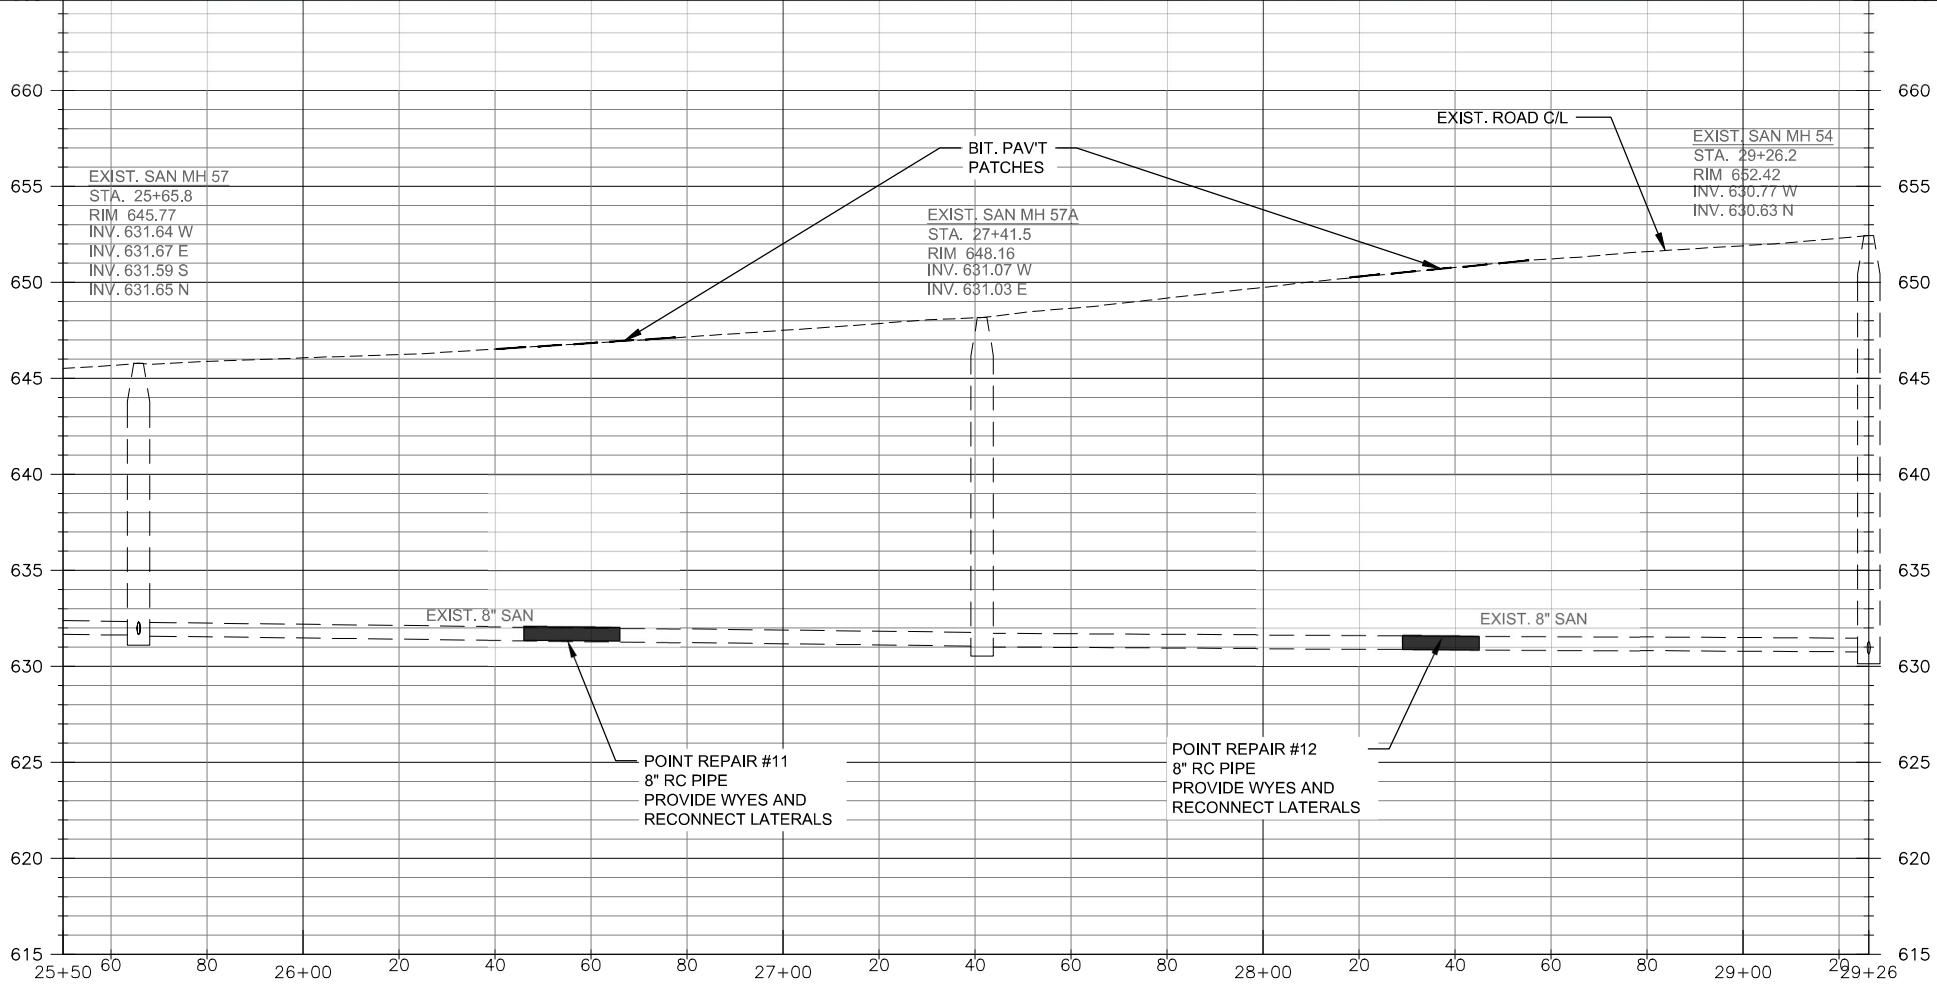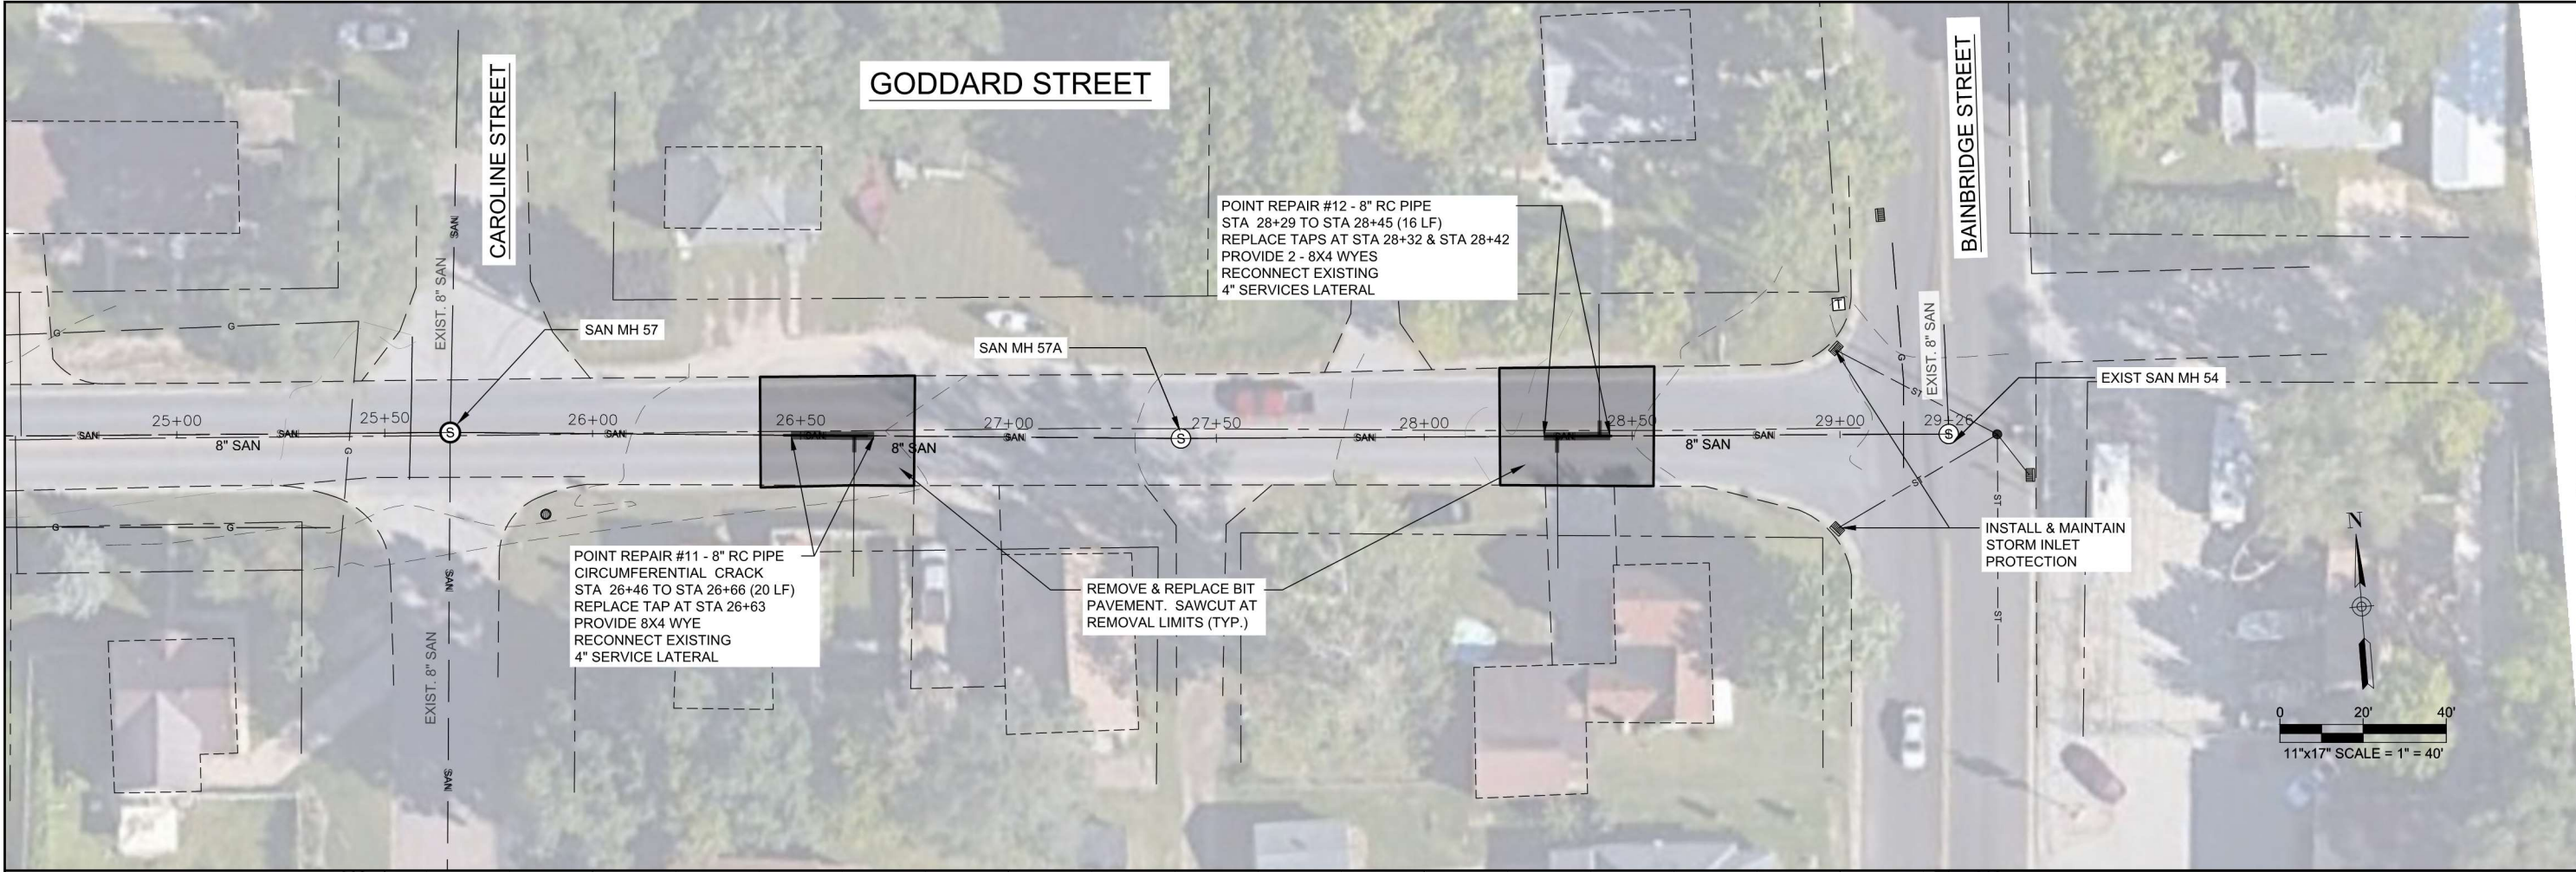

PROJECT NUMBER 1331-177.020		PROJECT NO. 13		GODDARD ST POINT REPAIRS 2023 SEWER REHABILITATION TOWN OF CAMPBELL, WISCONSIN		 DAVY ENGINEERING CO. LA CROSSE, WISCONSIN		FIELDBOOK: SCALE: AS SHOWN DRAWN: KK/CSM CHECKED: CRH DATE: 01/19/2023		REVISION DATE		REMARKS	
--------------------------------	--	-------------------	--	--	--	--	--	--	--	---------------	--	---------	--